



THIS DRAWING IS THE PROPERTY OF TNS. IT IS TO BE USED FOR THE PROJECT AND NOT BE REPRODUCED OR COPIED IN ANY MANNER WITHOUT THE WRITTEN CONSENT OF TNS. IT IS UNDERSTOOD AND AGREED THAT THE DRAWING AND INFORMATION HEREON WILL NOT BE USED FOR ANY OTHER PROJECT OR PURPOSE WITHOUT THE WRITTEN CONSENT OF TNS. THE ACCEPTANCE OF THIS DRAWING CONSTITUTES ACCEPTANCE OF THE FOREGOING AGREEMENT.

MATCH LINE
SEE SHT V1.1

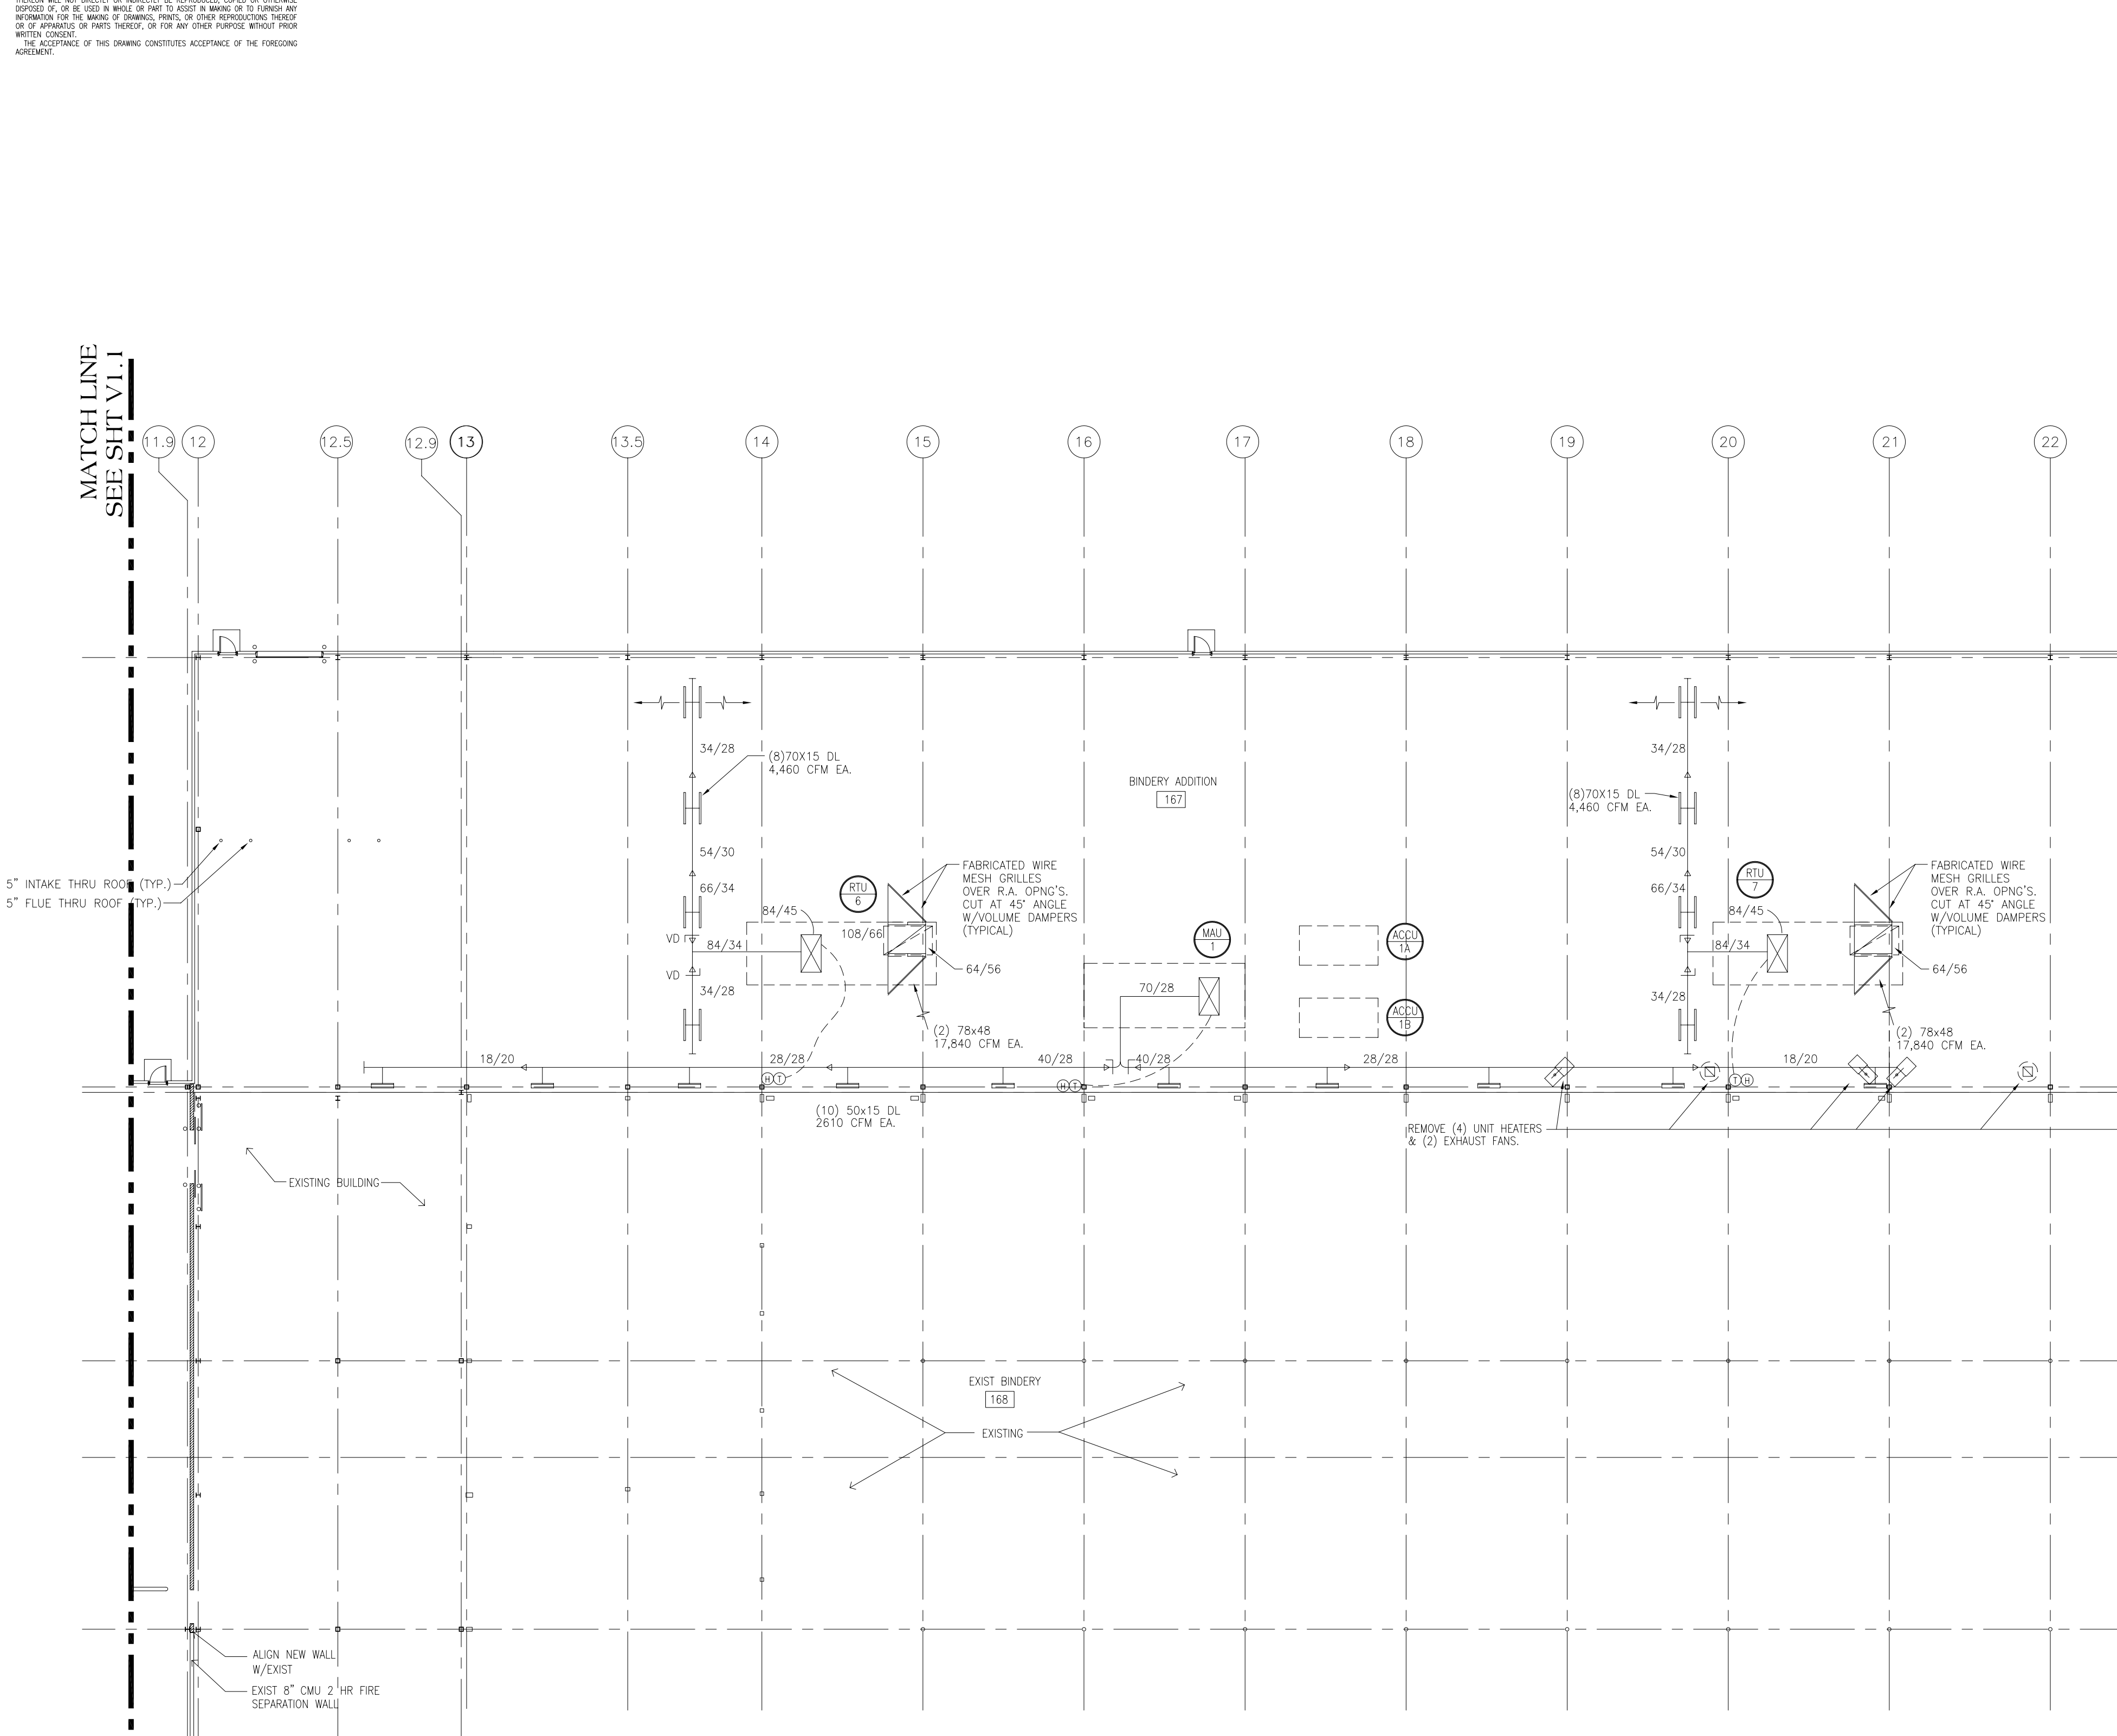


PARTIAL FLOOR PLAN-SOUTH SECTION
SCALE: 1/16" = 1' - 0"
NORTH


MATCH LINE
SEE SHT V1.1

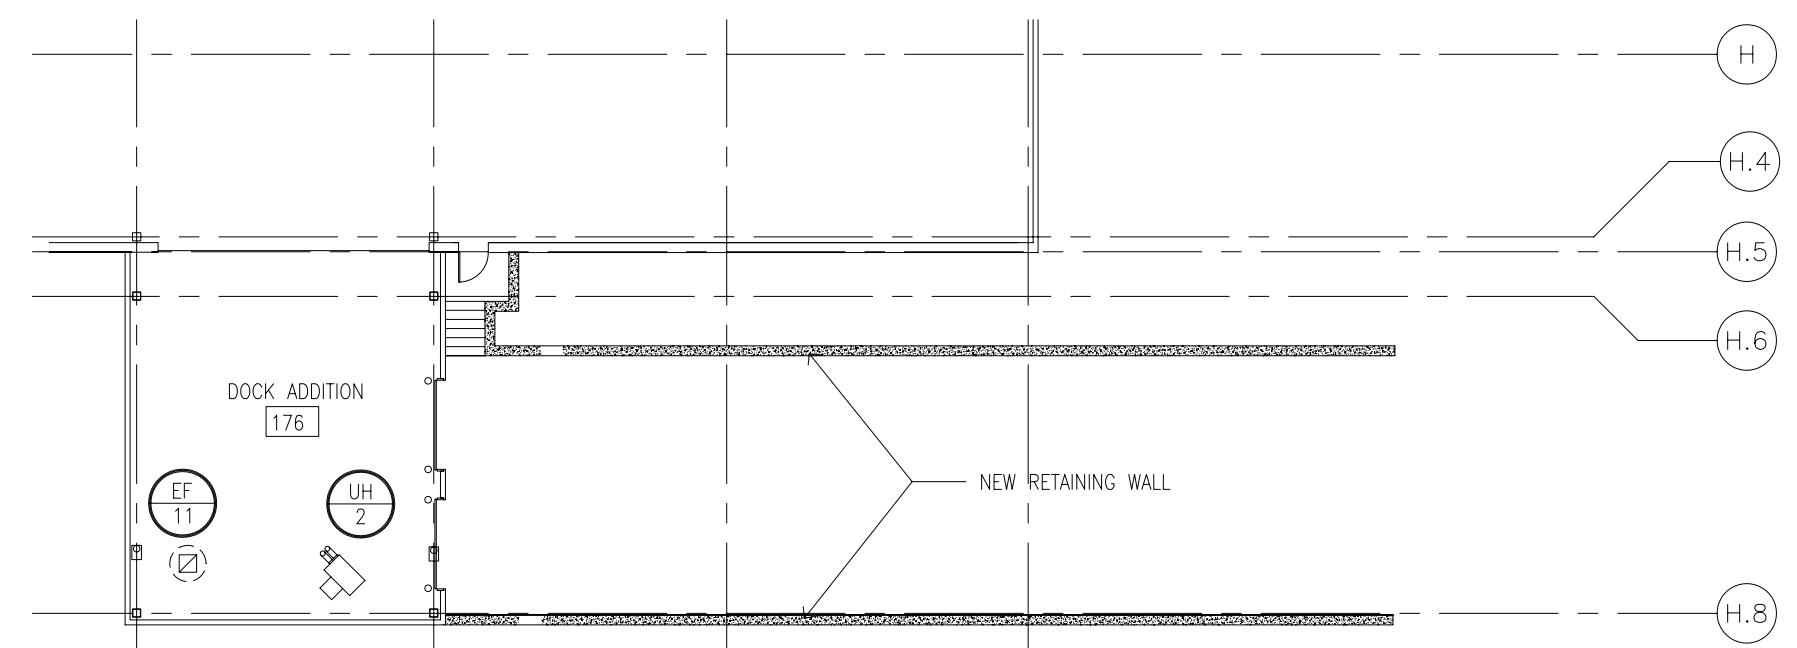

PARTIAL FLOOR PLAN OF DOCK ADDITION
SCALE: 1/16" = 1' - 0"
NORTH

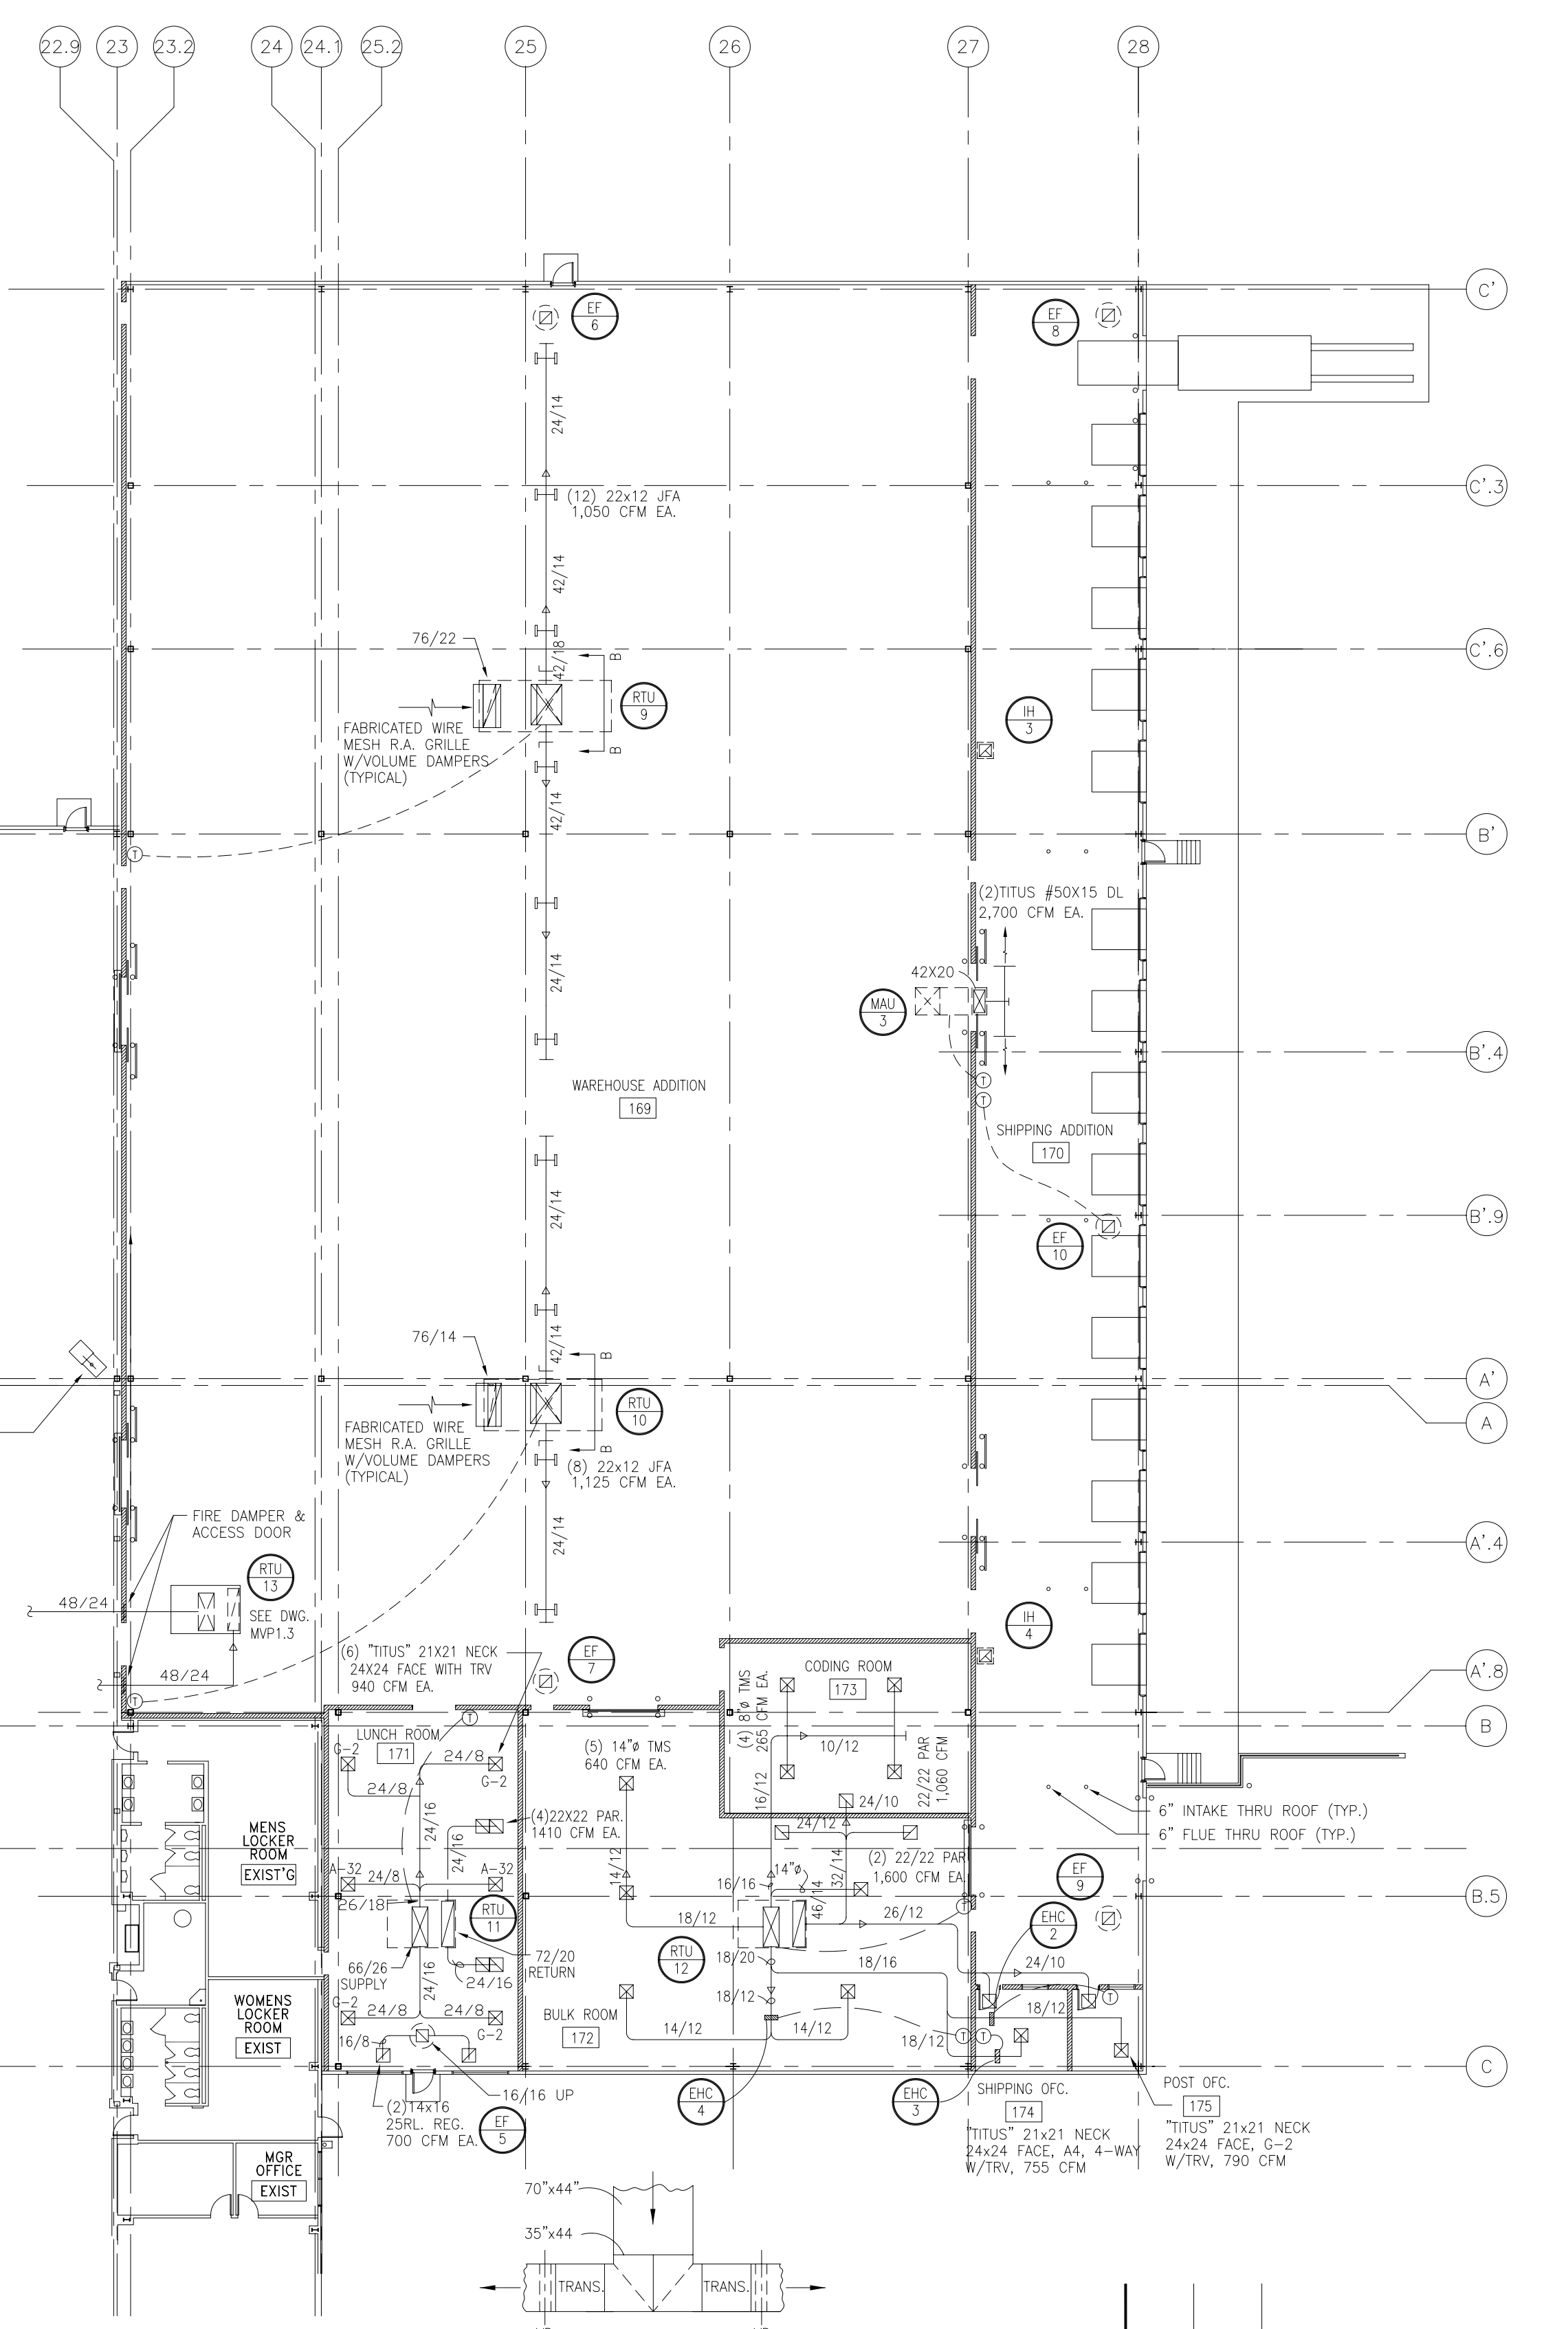

SECTION B-B
SCALE: 1/8" = 1' - 0"

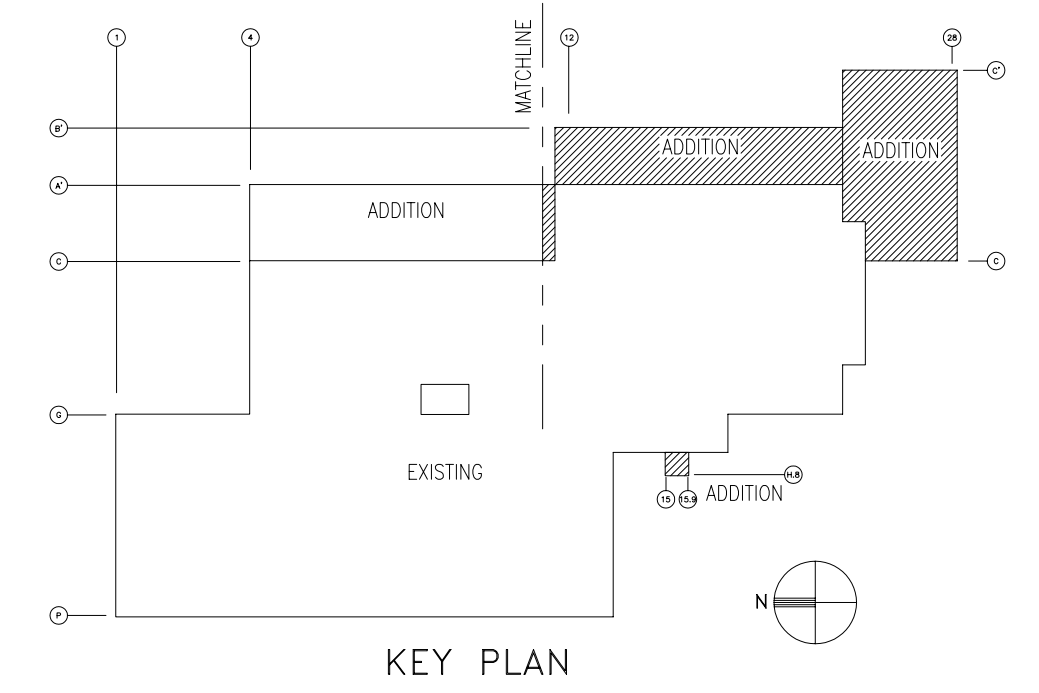

ATTENTION
This drawing is PRELIMINARY and
is not intended for Construction.

9-13-00	ISSUED FOR BIDDING & PERMITS
4-24-00	ISSUED FOR BIDDING
4-14-00	ISSUED FOR OWNER'S REVIEW

REV.	DATE	DESCRIPTION
------	------	-------------

VENTILATION PLAN - SOUTH

tms PLANNERS
DESIGNERS
ENGINEERS

2101 Hammond Drive Schaumburg, Illinois 60173
Phone: 847-397-2100 Fax: 847-397-8980

BROWN PRINTING
PRESS ROOM, BINDERY
AND WAREHOUSE
EXPANSION

11595 McCONNELL ROAD WOODSTOCK, ILLINOIS

DWN. BY	SCALE	DWG. NO.
APP. BY	1/16" = 1'-0"	V1.2
CKD. BY	JOB NO. 6518/6523	
	DATE 4/13/00	